


**ROOF & FRAMING PLANS**  
SCALE 1:100 m.

REV. NO.	DATE	CHECKED	APPROVED	REMARKS
REVISIONS				


SURVEYED :  
DESIGNED : MWSS EXISTING DESIGNED  
DRAWN : W.F. GONZALES  
CHECKED :

REPUBLIC OF THE PHILIPPINES  
**METROPOLITAN WATERWORKS AND SEWERAGE SYSTEM**  
KATIPUNAN ROAD, BALARA QUEZON CITY


SUBMITTED FOR APPROVAL

  
**RAMON R. FABUL**  
OIC, DIVISION MANAGER FOR ENGG.


RECOMMENDING APPROVAL

  
**LEONOR C. CEOFAS, CES0 IV**  
P.A. FOR ENGG. & OPERATION


APPROVED :

  
**PDDG. REYNALDO V. VELASCO (Ref)**  
ADMINISTRATOR

PROJECT :	<b>PROPOSED RENOVATION OF MWSS ARROCEROS MAIN BUILDING</b>	SHEET
LOCATION :	ARROCEROS STREET MANILA	SCALE
SHEET CONTENTS :	ROOF & FRAMING PLANS	DATE :

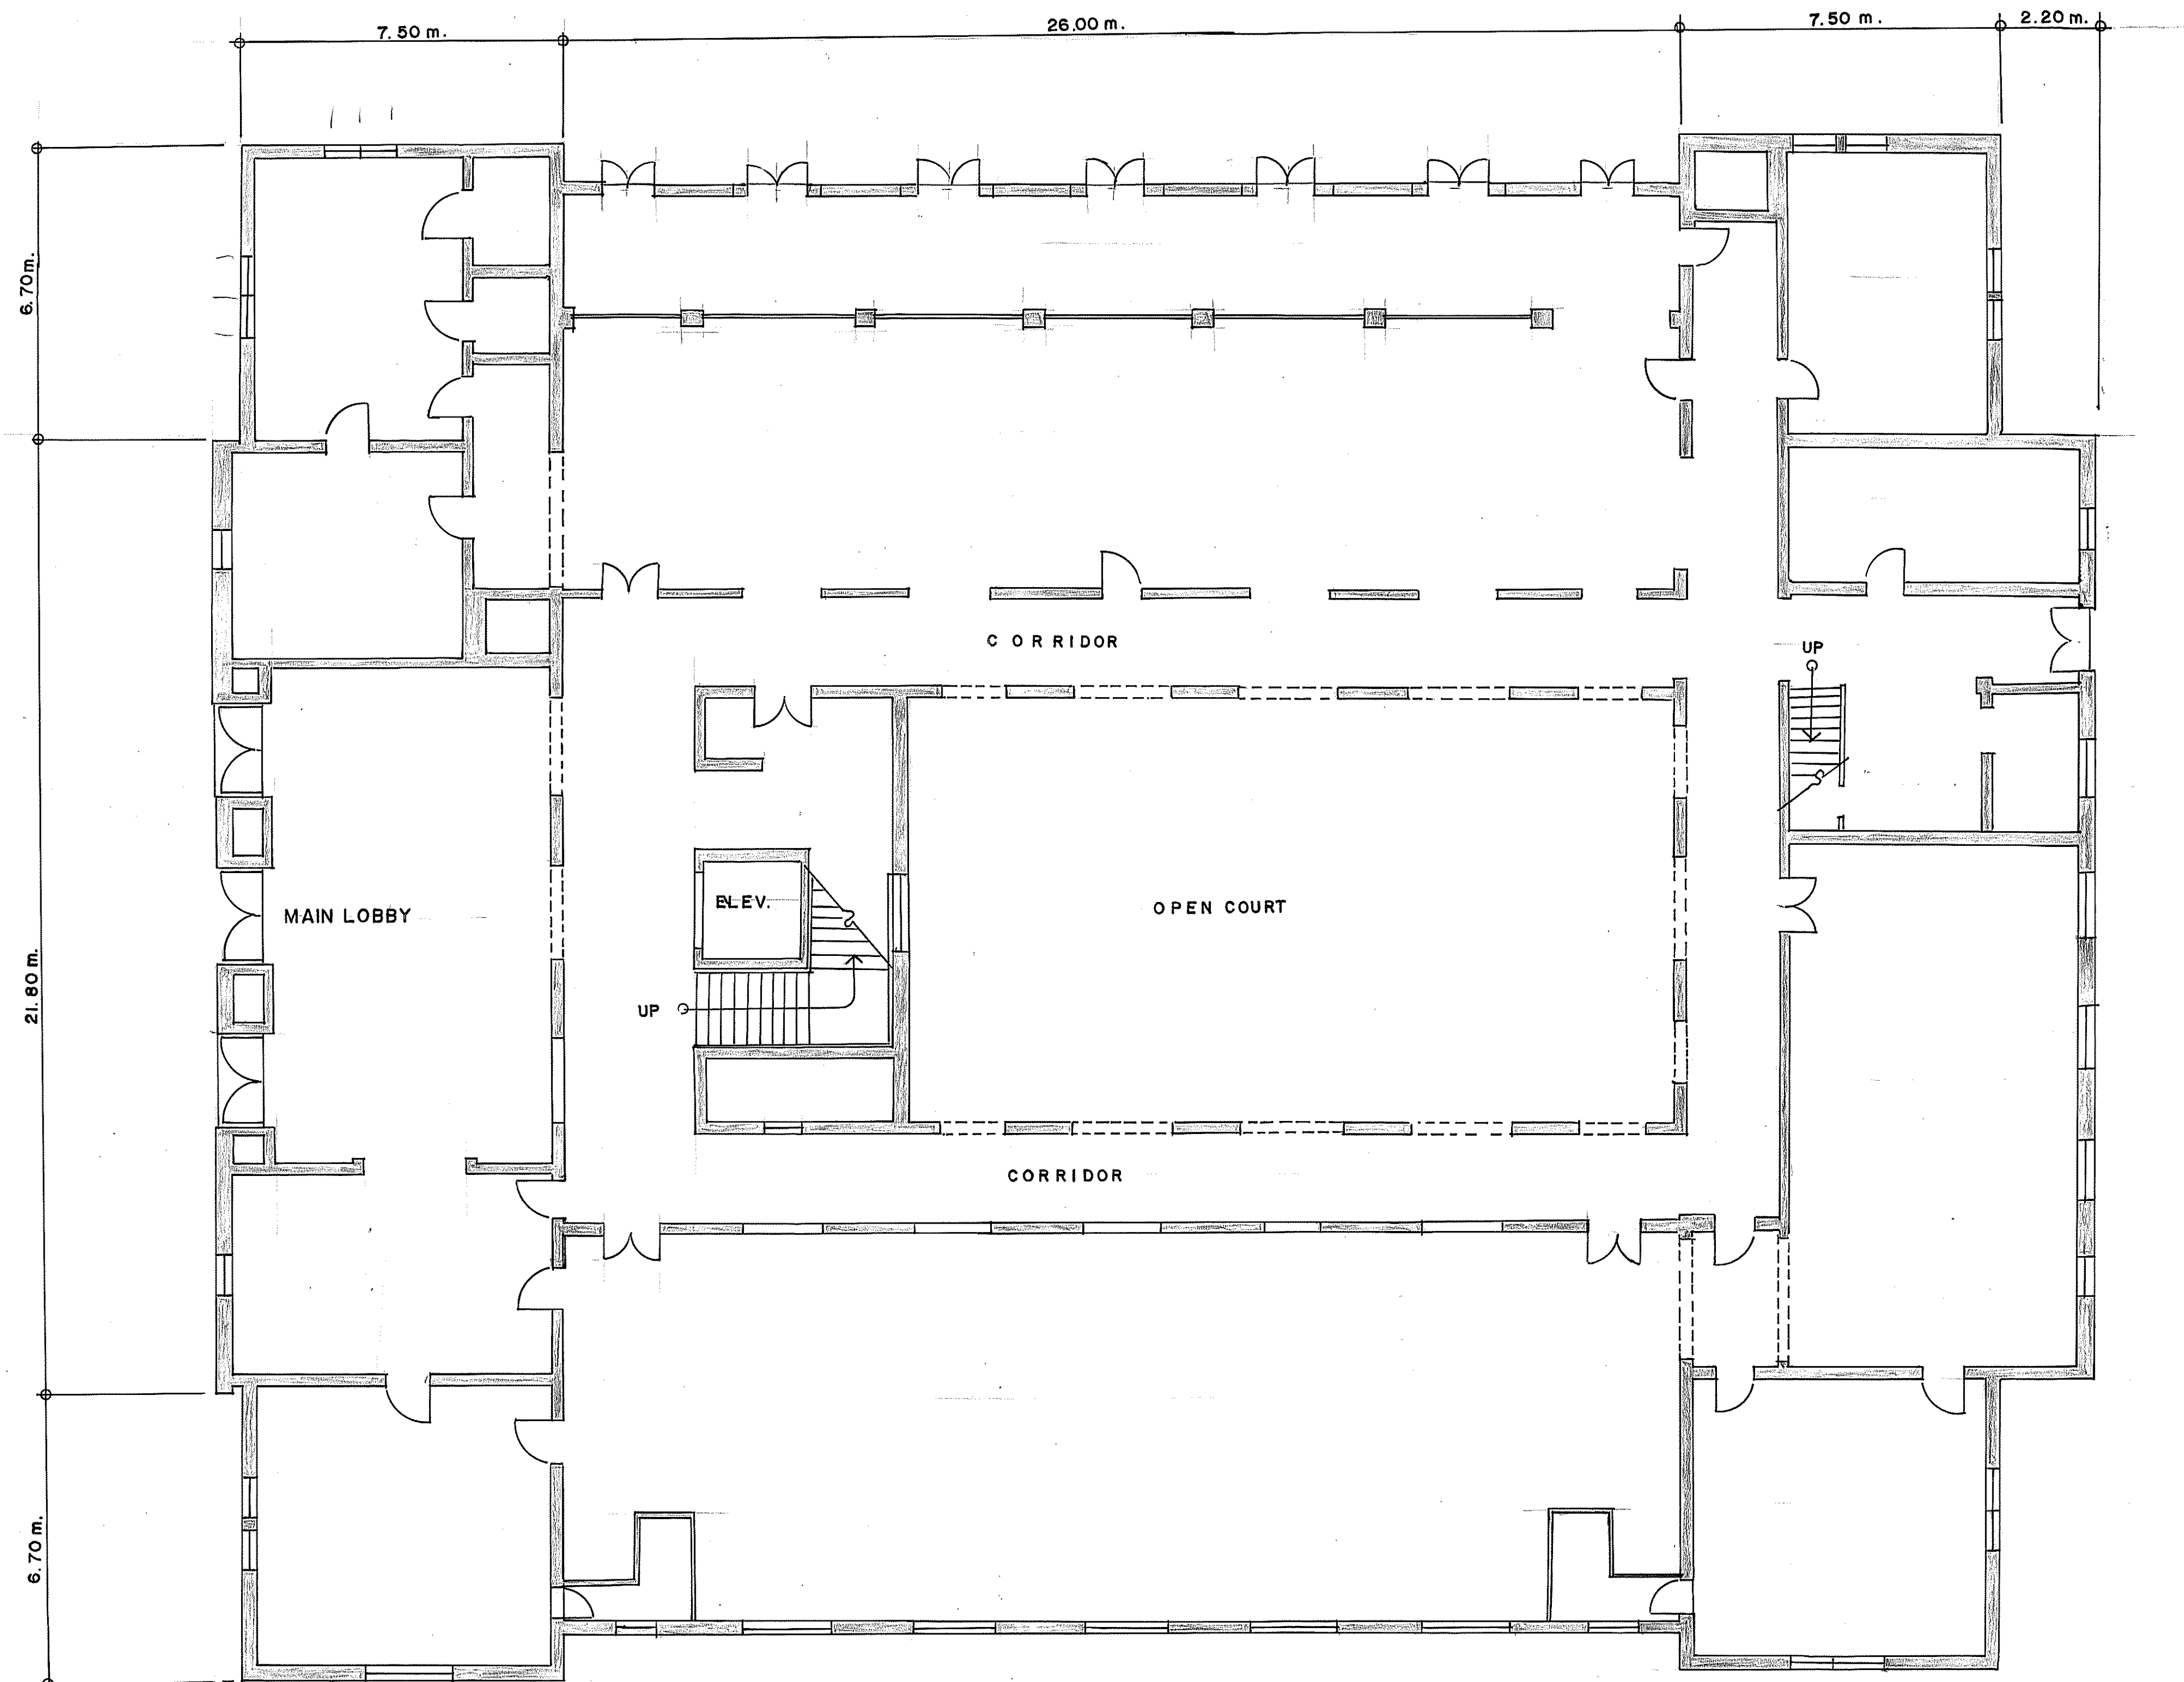

**GROUND FLOOR PLAN**  
SCALE 1:100 m

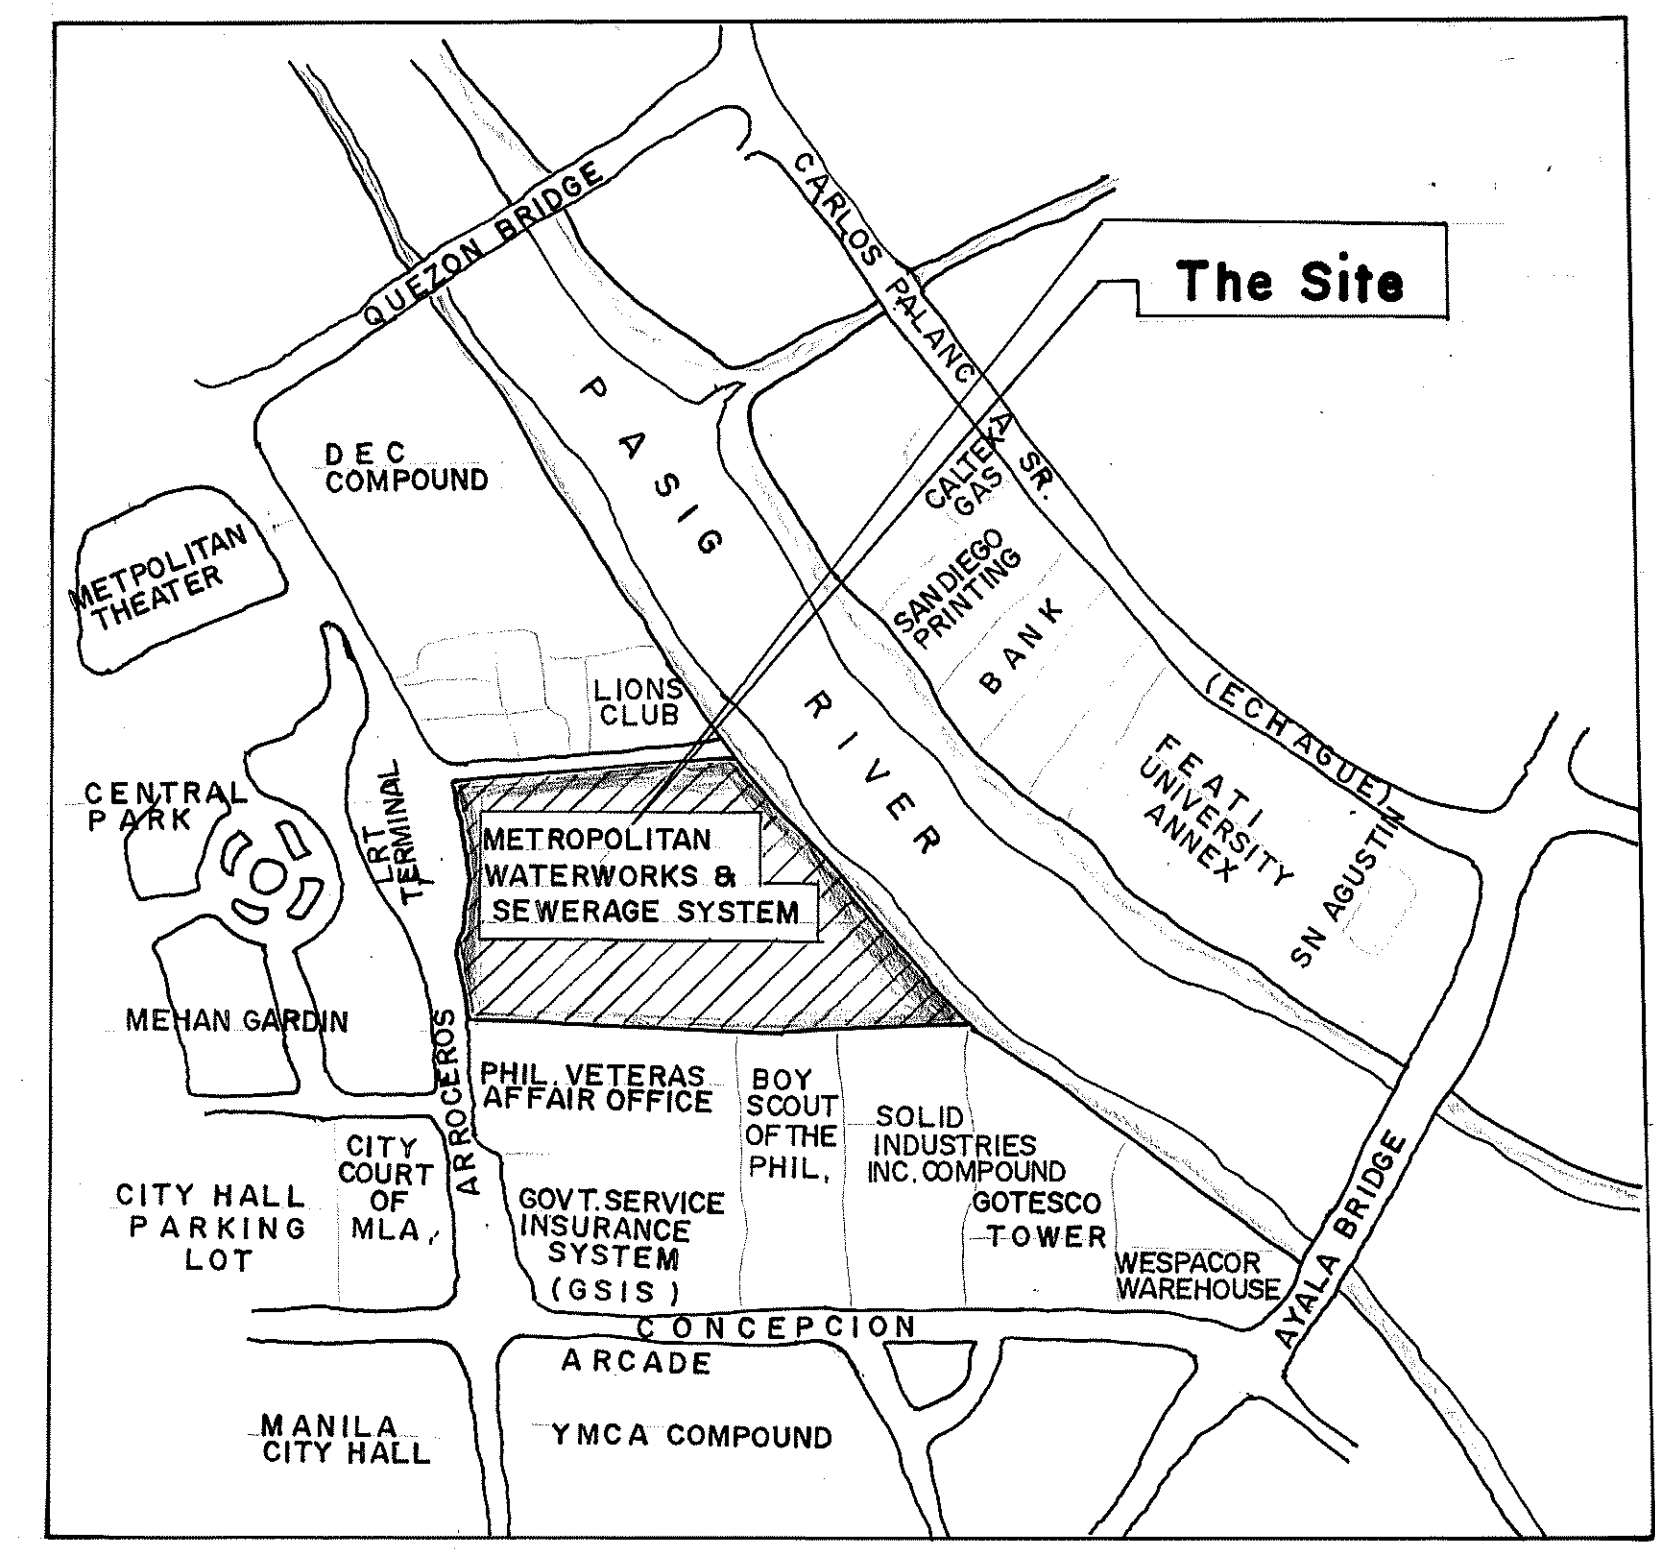

**VICINITY MAP**  
NOT TO SCALE

REV. NO.	DATE	CHECKED	APPROVED	REMARKS
REVISIONS				

SURVEYED:  
DESIGNED: MWSS EXISTING DESIGNED  
DRAWN: W.F. GONZALES  
CHECKED:

REPUBLIC OF THE PHILIPPINES  
**METROPOLITAN WATERWORKS AND SEWERAGE SYSTEM**  
KATIPUNAN ROAD, BALARA QUEZON CITY

SUBMITTED FOR APPROVAL: **RAMON FABUL**  
D.I.C., DIVISION MANAGER FOR ENGG.

RECOMMENDING APPROVAL: **LEONOR C. CLEOPAS, CESO IV**  
D/A. FOR ENGG. & OPERATION


APPROVED: **PDDG. REYNALDO M. VELASCO (Ret)**  
ADMINISTRATOR

PROJECT: **PROPOSED RENOVATION OF MWSS ARROCEROS MAIN BUILDING**

LOCATION: **ARROCEROS STREET MANILA**


SHEET CONTENTS: **GROUND FLOOR PLAN, VICINITY MAP**

SHEET: \_\_\_\_\_  
SCALE: \_\_\_\_\_  
DATE: \_\_\_\_\_

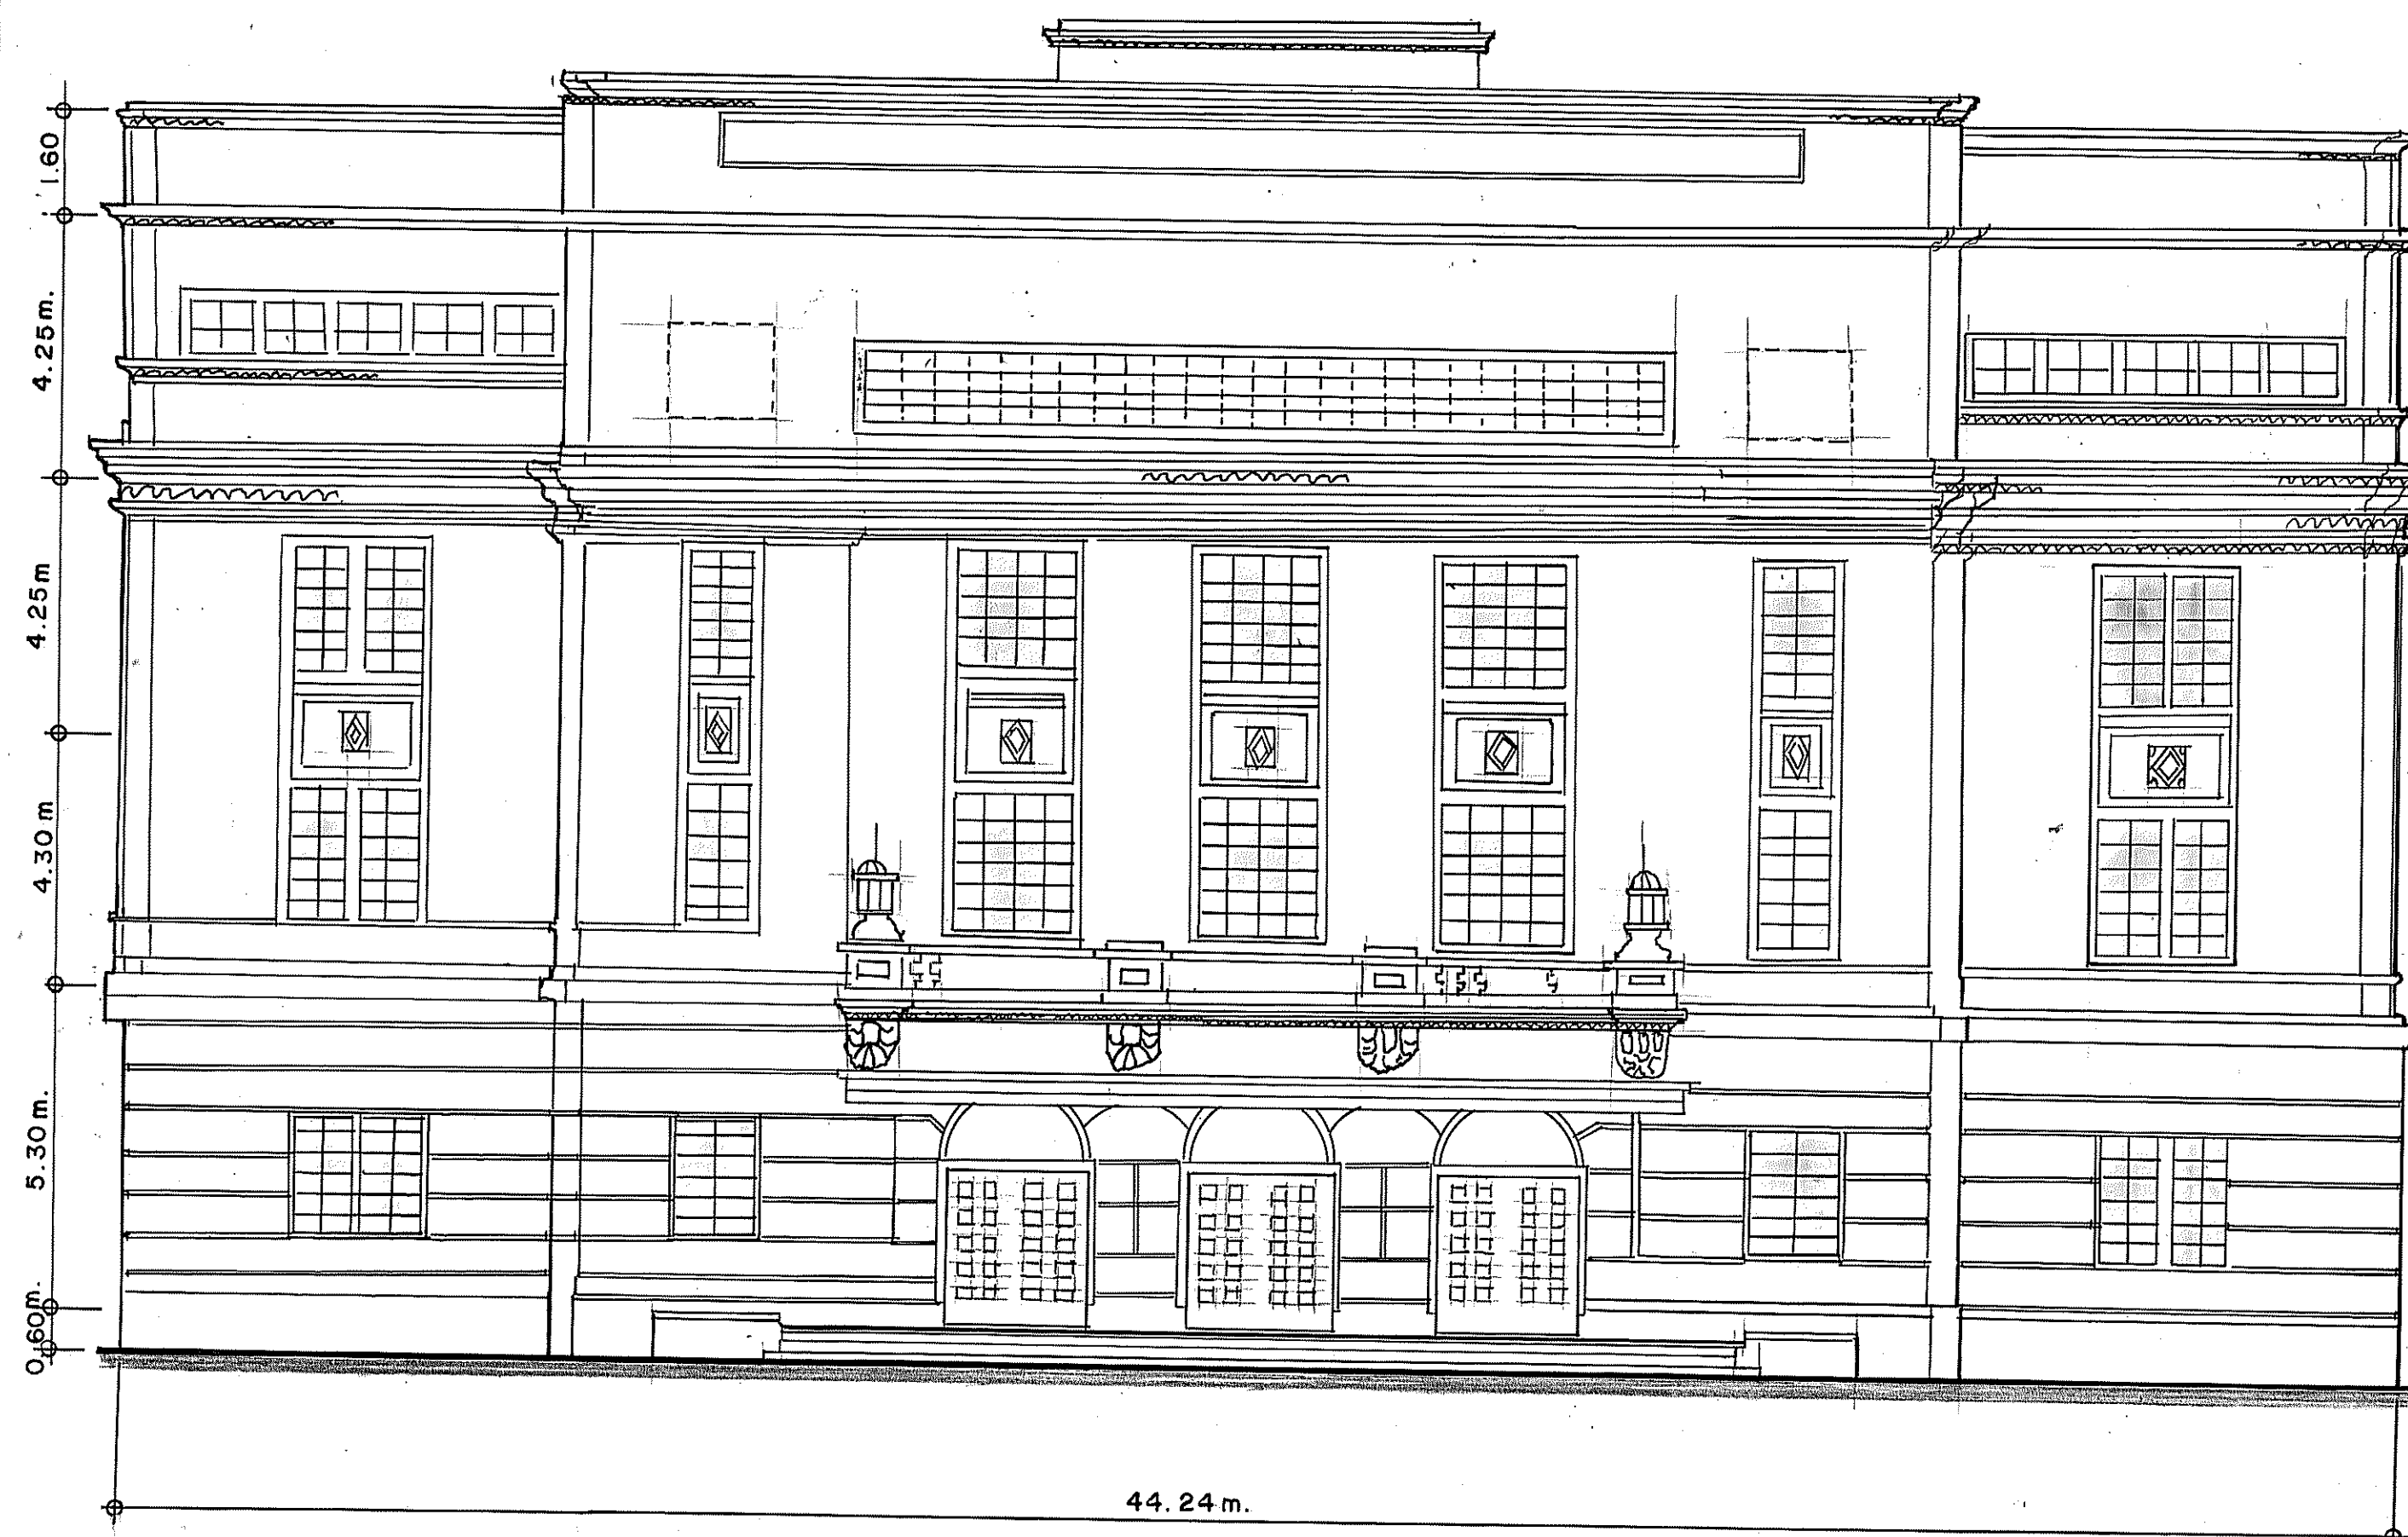

**FRONT ( WEST) ELEVATION**

SCALE 1:100 m.

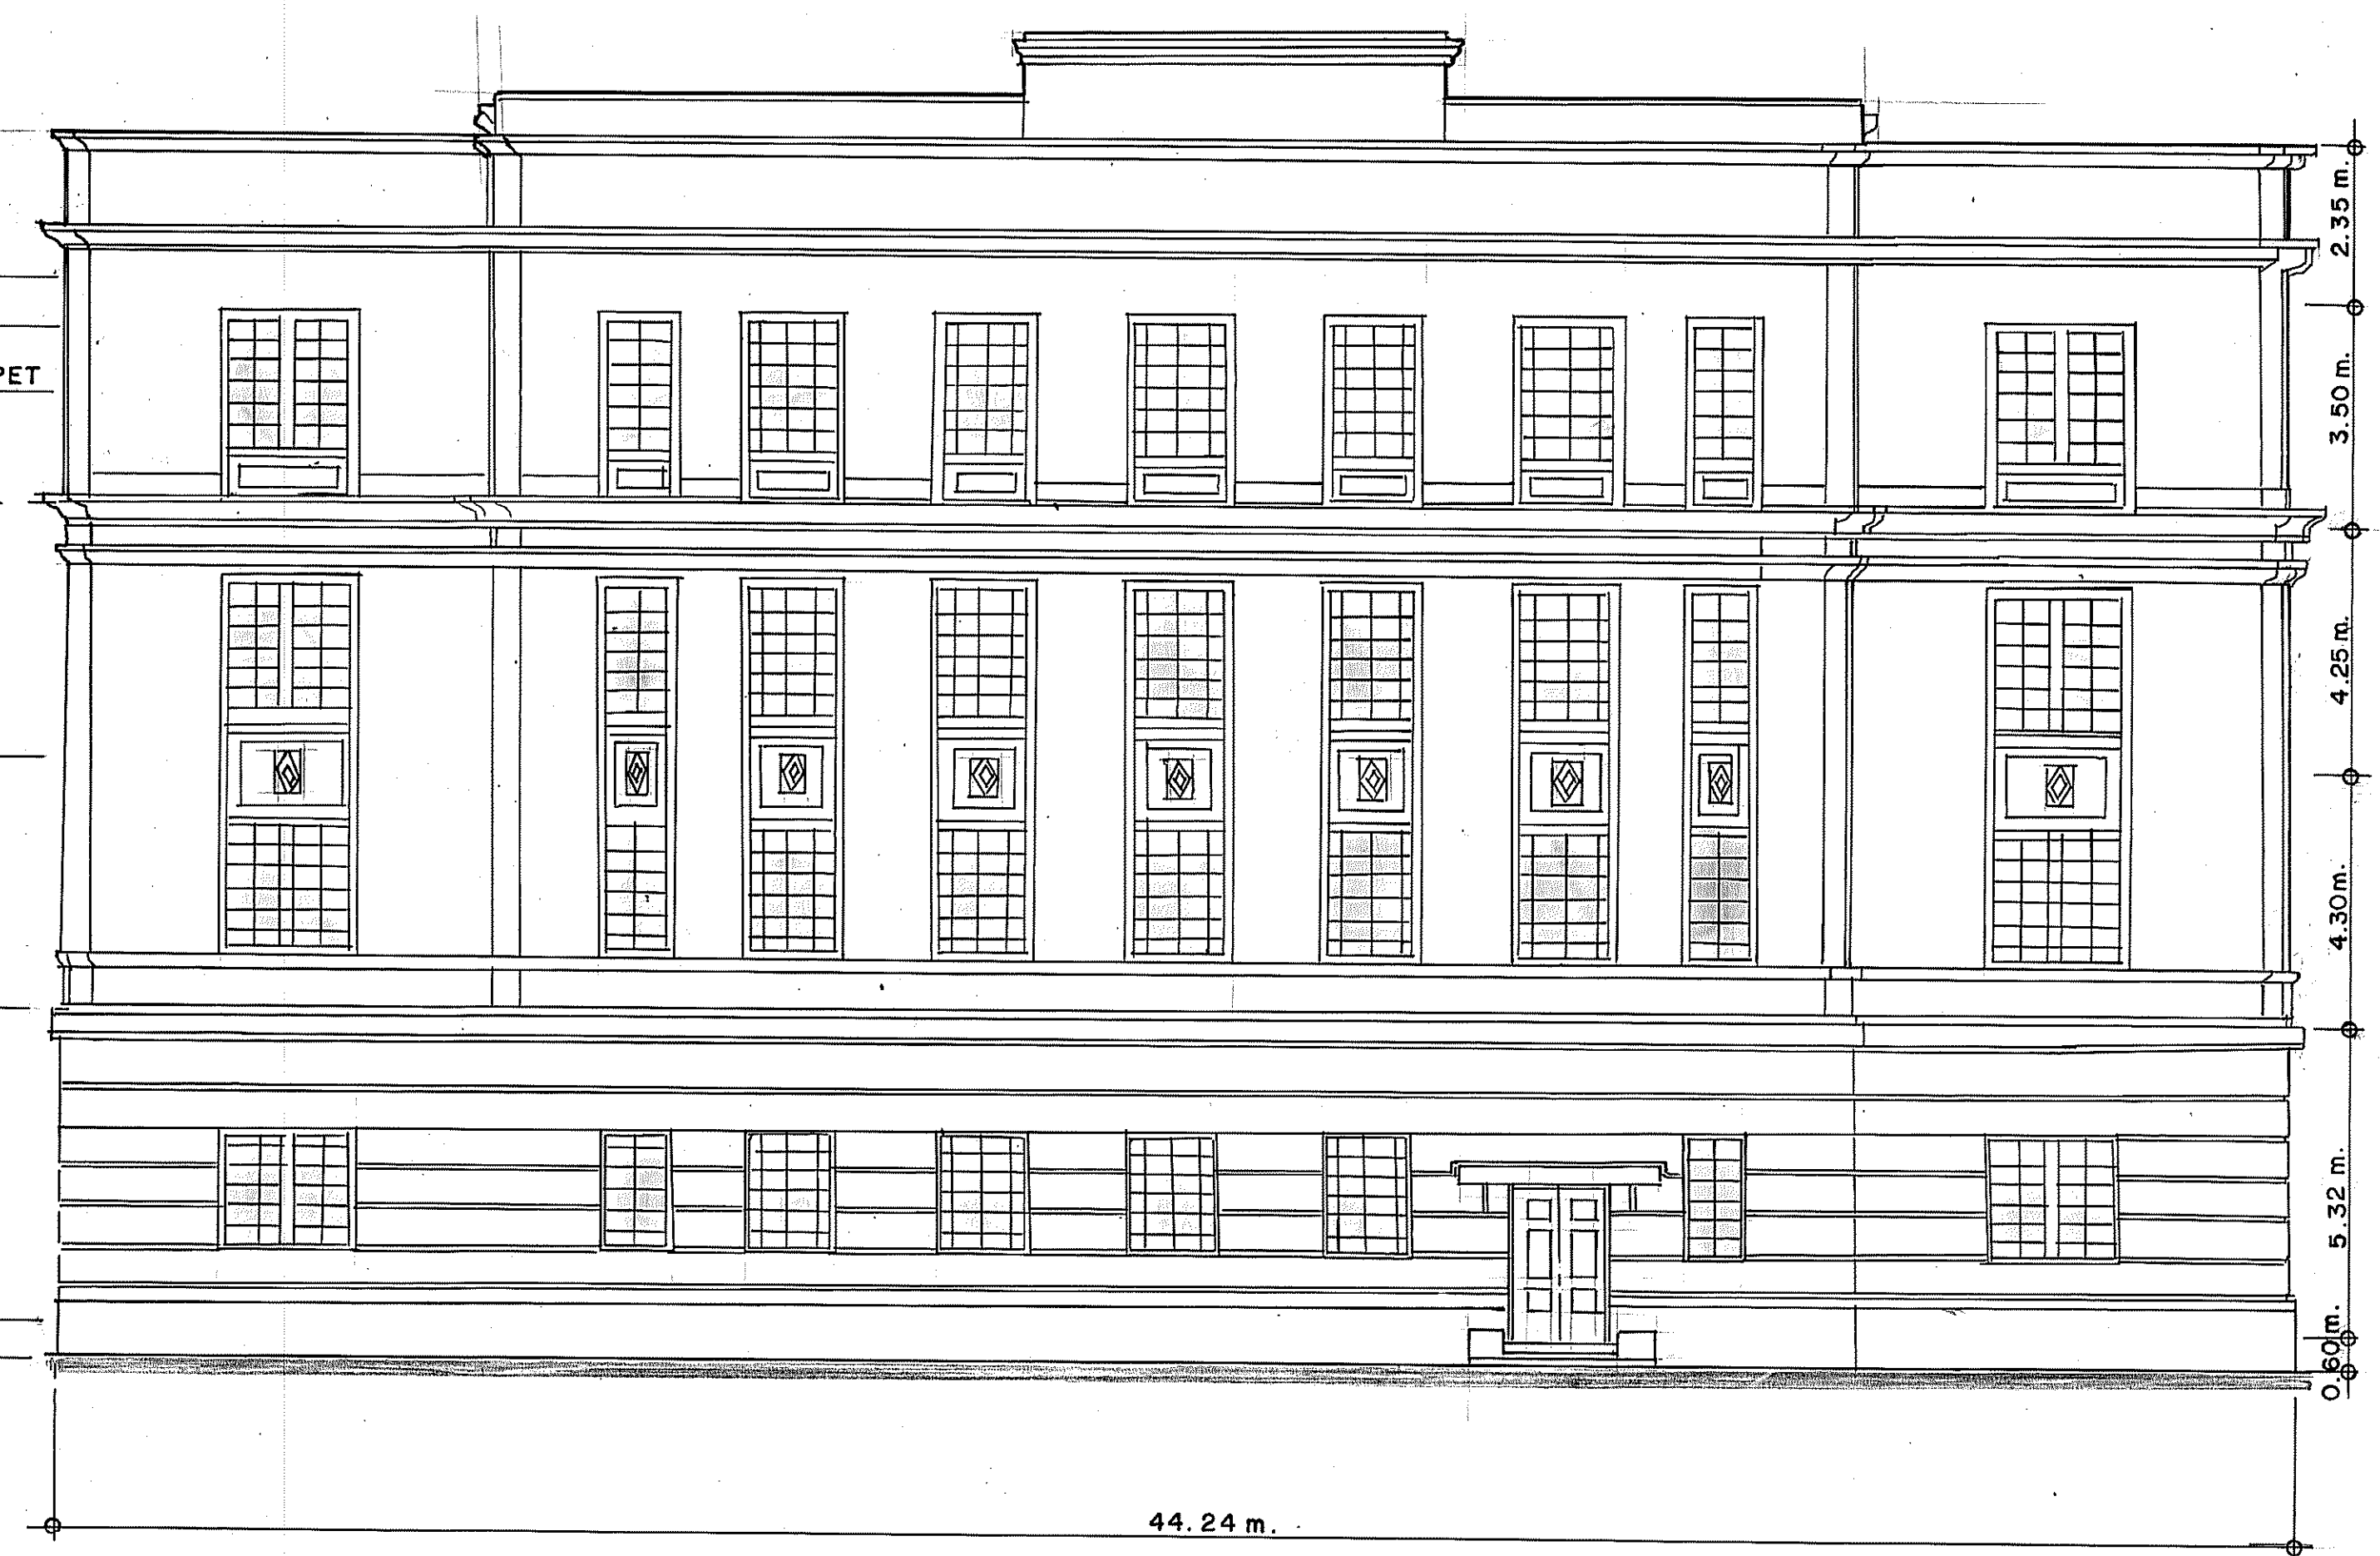


**REAR ( EAST) ELEVATION**


SCALE 1:100 m.


REV. NO.	DATE	CHECKED	APPROVED	REMARKS
R I V I S I O N S				

SURVEYED :  
 DESIGNED : MWSS EXISTING DESIGNED  
 DRAWN : W.F. GONZALES  
 CHECKED :

REPUBLIC OF THE PHILIPPINES  
**METROPOLITAN WATERWORKS AND SEWERAGE SYSTEM**  
 KATIPUNAN ROAD, BALARA QUEZON CITY

SUBMITTED FOR APPROVAL:   
 RANCO FABUL  
 OIC, DIVISION MANAGER FOR ENGG.

RECOMMENDING APPROVAL:   
 LEONOR C. CLEONAS, CESO IV  
 D.A. FOR ENGG. & OPERATION

APPROVED:   
 PDDG. REYNALDO V. VELASCO (Ref.)  
 ADMINISTRATOR

PROJECT : **PROPOSED RENOVATION OF MWSS ARROCEROS MAIN BUILDING**

LOCATION : **ARROCEROS STREET MANILA**

SHEET CONTENTS : **FRONT ( WEST ) ELEVATION , REAR ( EAST ) ELEVATION**

SHEET
SCALE
DATE :